



**FLAT ROCK - NEW HVAC UPGRADE SYSTEMS - ENLARGED FLOOR PLAN @
NEW HVAC UPGRADE VRV ZONE NO. 4**
SCALE: 1/8" = 1'-0"

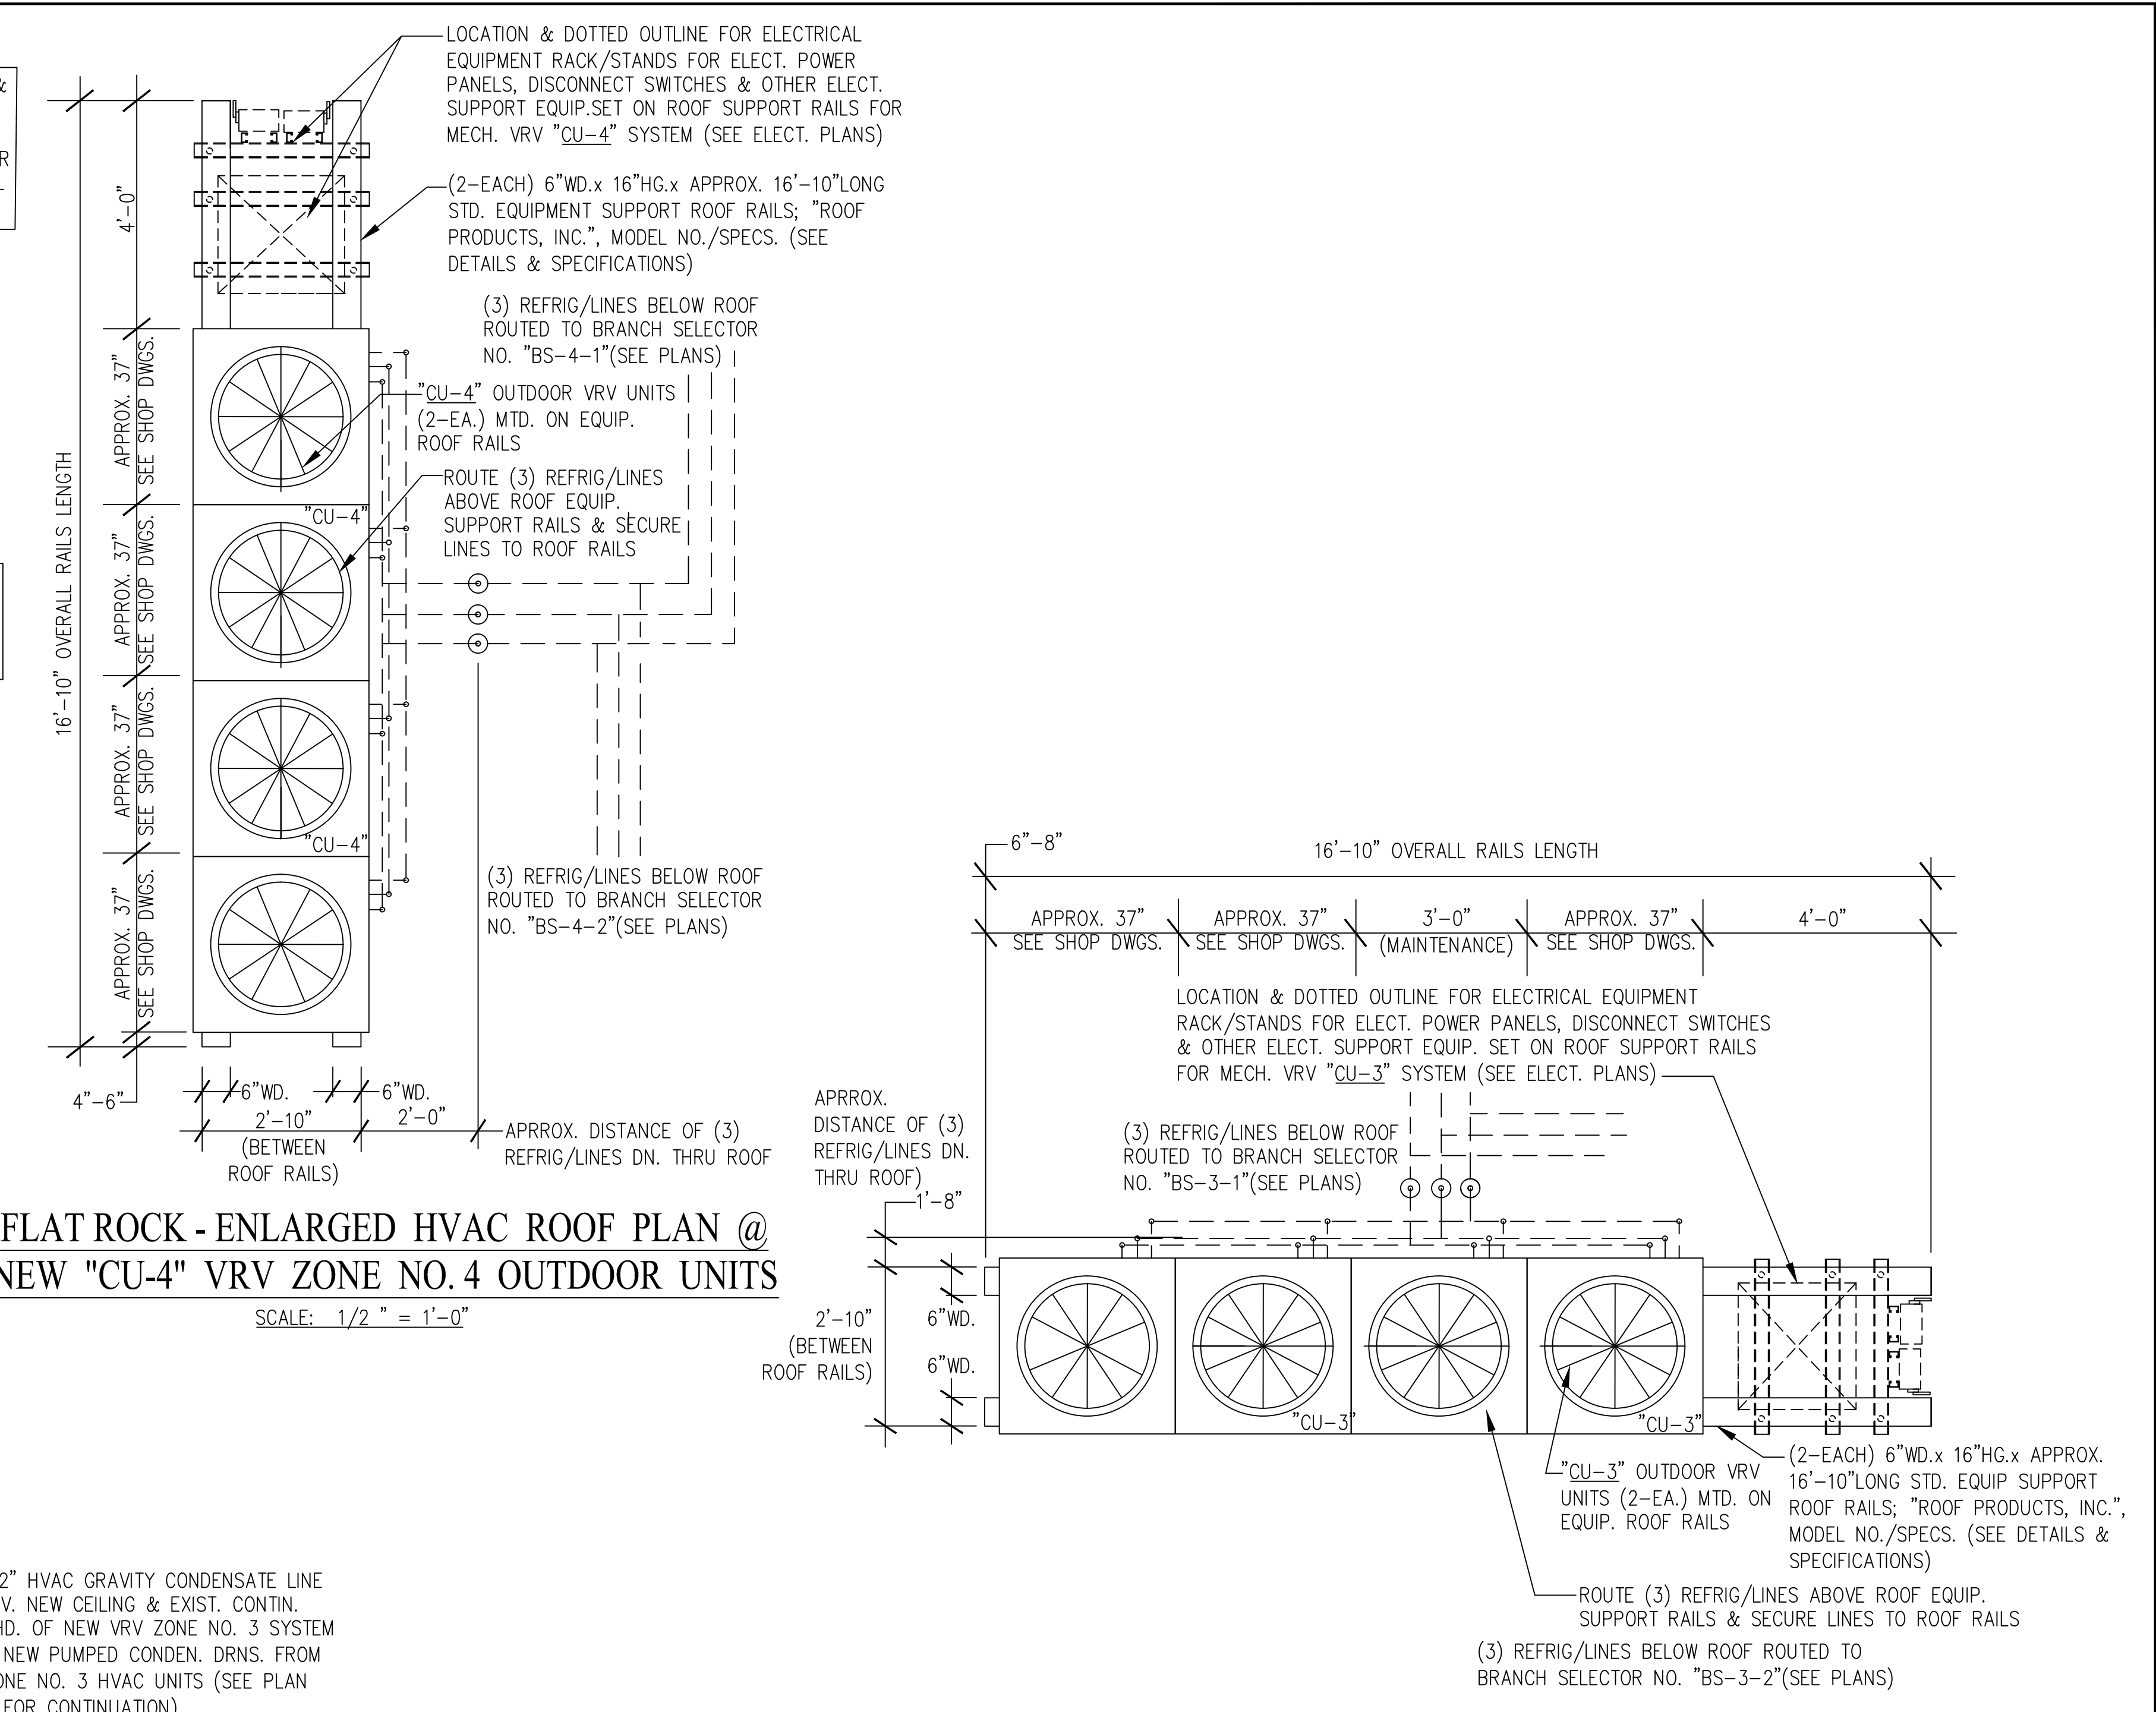

**FLAT ROCK - ENLARGED HVAC ROOF PLAN @
NEW "CU-4" VRV ZONE NO. 4 OUTDOOR UNITS**
SCALE: 1/2" = 1'-0"

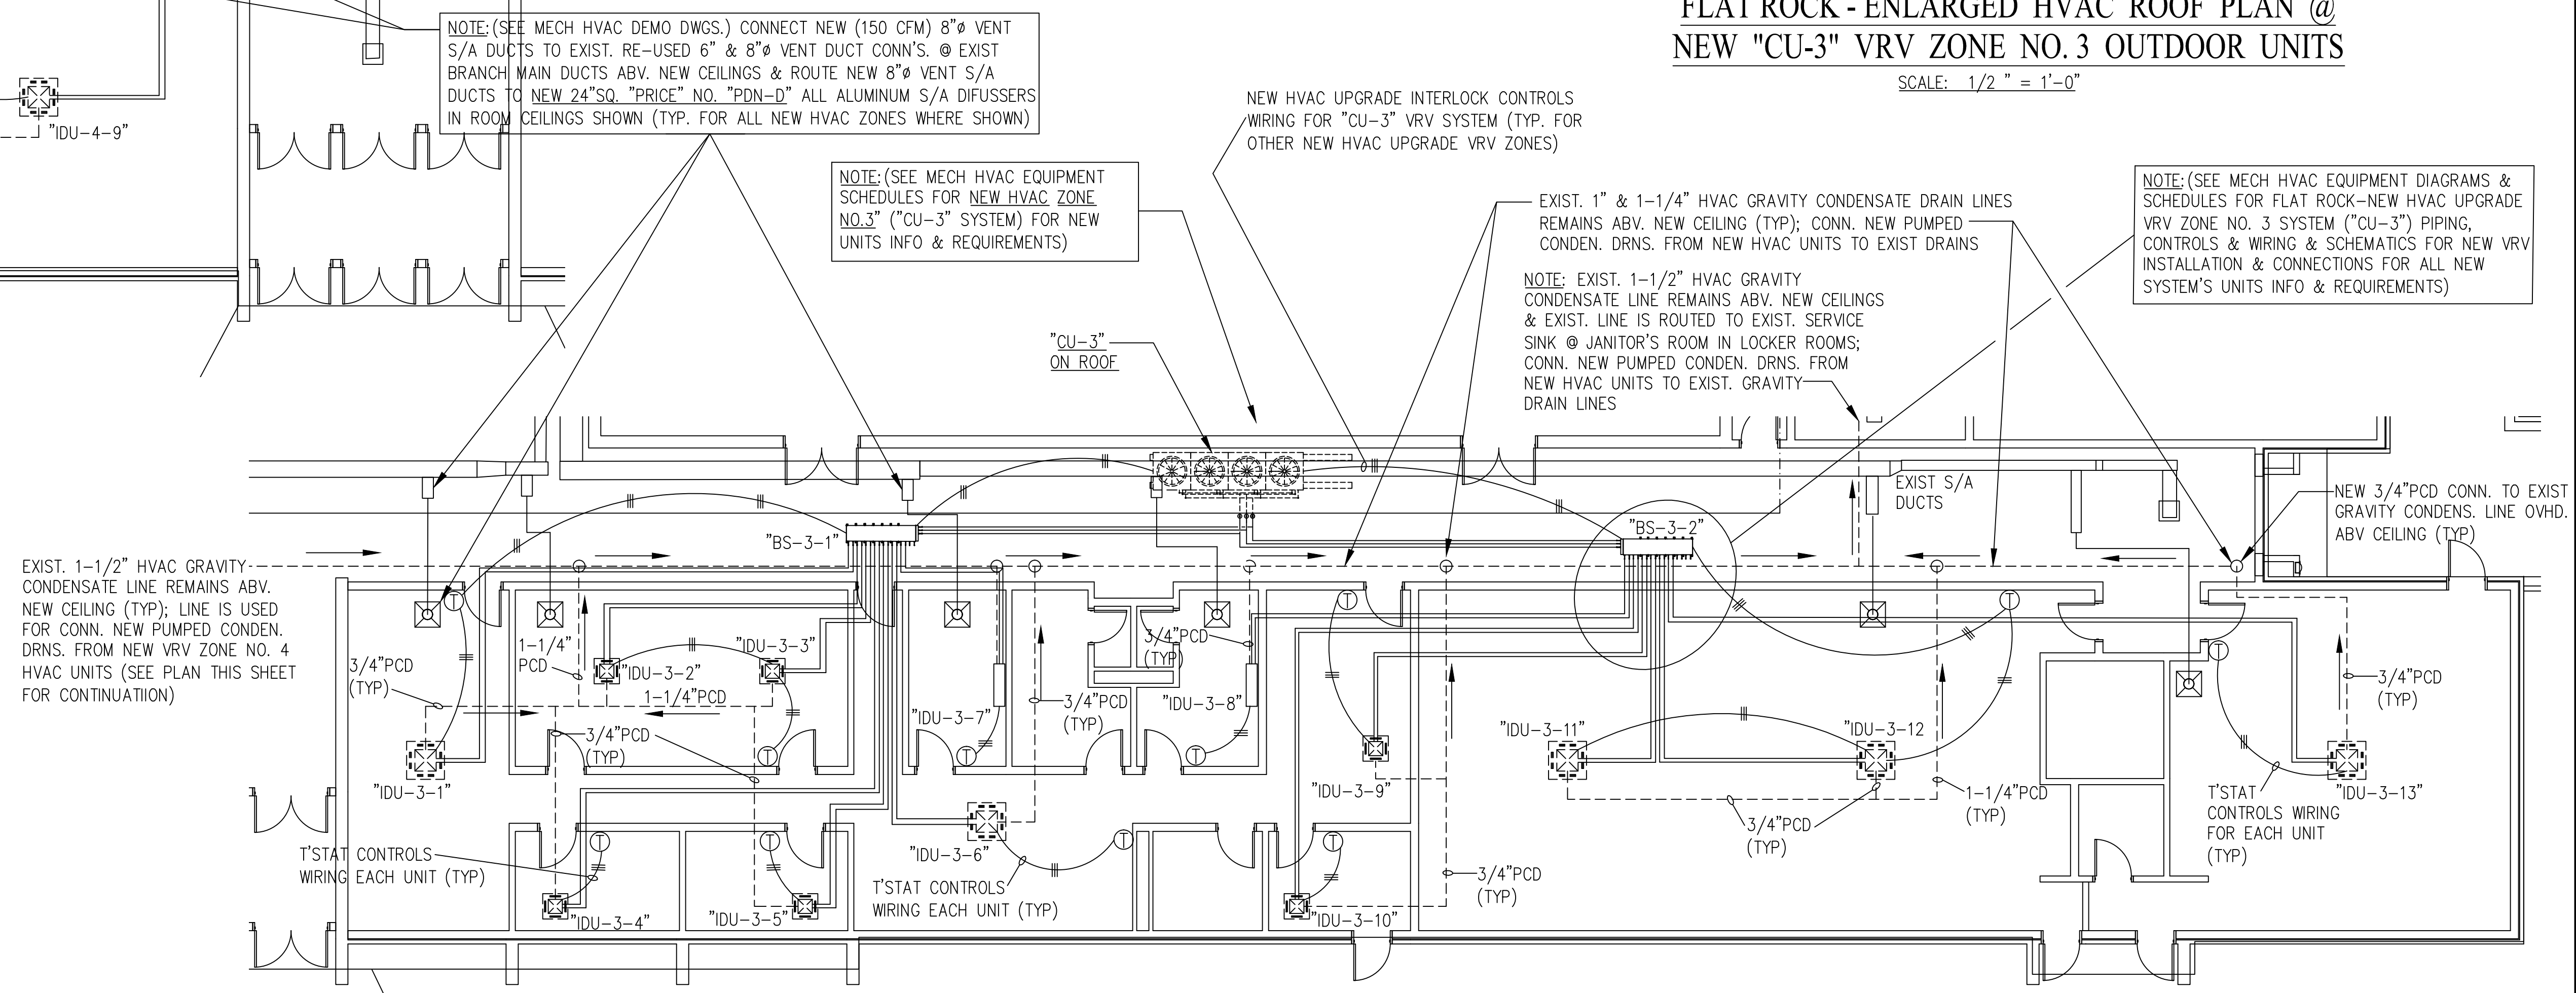

**FLAT ROCK - NEW HVAC UPGRADE SYSTEMS - ENLARGED FLOOR PLAN @
NEW HVAC UPGRADE VRV ZONE NO. 3**
SCALE: 1/8" = 1'-0"

NO.	DATE	ISSUED FOR OWNER BIDDING.	DESCRIPTION	BY
1	DEC. 16, 2019	ISSUED FOR OWNER BIDDING.		JJC

DESIGNED BY: S. BRAUNBECK & J. CAPITAN
 DRAWN BY: CAPITAN
 CHECKED BY: CAPITAN
 DATE: DECEMBER-16-2019
 SCALE: AS NOTED
 JOB NO.: DEI JOB NO. 19005

DESIGN & ENGINEERING
 ENERGY SYSTEMS
 INFRASTRUCTURE UTILITIES
 SYSTEMS ANALYSIS
 COMMISSIONING REVIEW

DELTA
 DELTA ENGINEERING, INC. CONSULTING ENGINEERS
 315 EAST BROAD STREET, GREENVILLE, SC 29601
 GREENVILLE, SC TEL. NO. (864) 505-5358
 3106 RIVERVIEW VIEW, CHARLESTON, SC 29414
 CHARLESTON, SC TEL. NO. (864) 505-2976
 Em: jcapitan@gmail.com

THIS DRAWING IS THE PROPERTY AND COPYRIGHT OF DELTA ENGINEERING, INC. AND SHALL NOT BE USED OR COPIED WITHOUT WRITTEN PERMISSION. COPYRIGHT ©

FLAT ROCK - NEW HVAC UPGRADE SYSTEMS ENLARGED FLOOR PLANS - VRV ZONES 3 & 4

PROJECT: **2019 - 2020 HVAC UPGRADES TO FLAT ROCK & RUGBY MIDDLE SCHOOLS**
 HENDERSON COUNTY PUBLIC SCHOOLS
 414 - 4TH STREET, HENDERSONVILLE, HENDERSON COUNTY, NORTH CAROLINA 29621

DRAWING: **FR-M-3**
 SHEET: 6 OF 10
 REV. NO.: IFOB