


**RUGBY - ENLARGED HVAC ROOF PLAN @ NEW "CU-4" VRV ZONE NO. 4 OUTDOOR UNITS (RUGBY)**

SCALE: 1/2" = 1'-0"

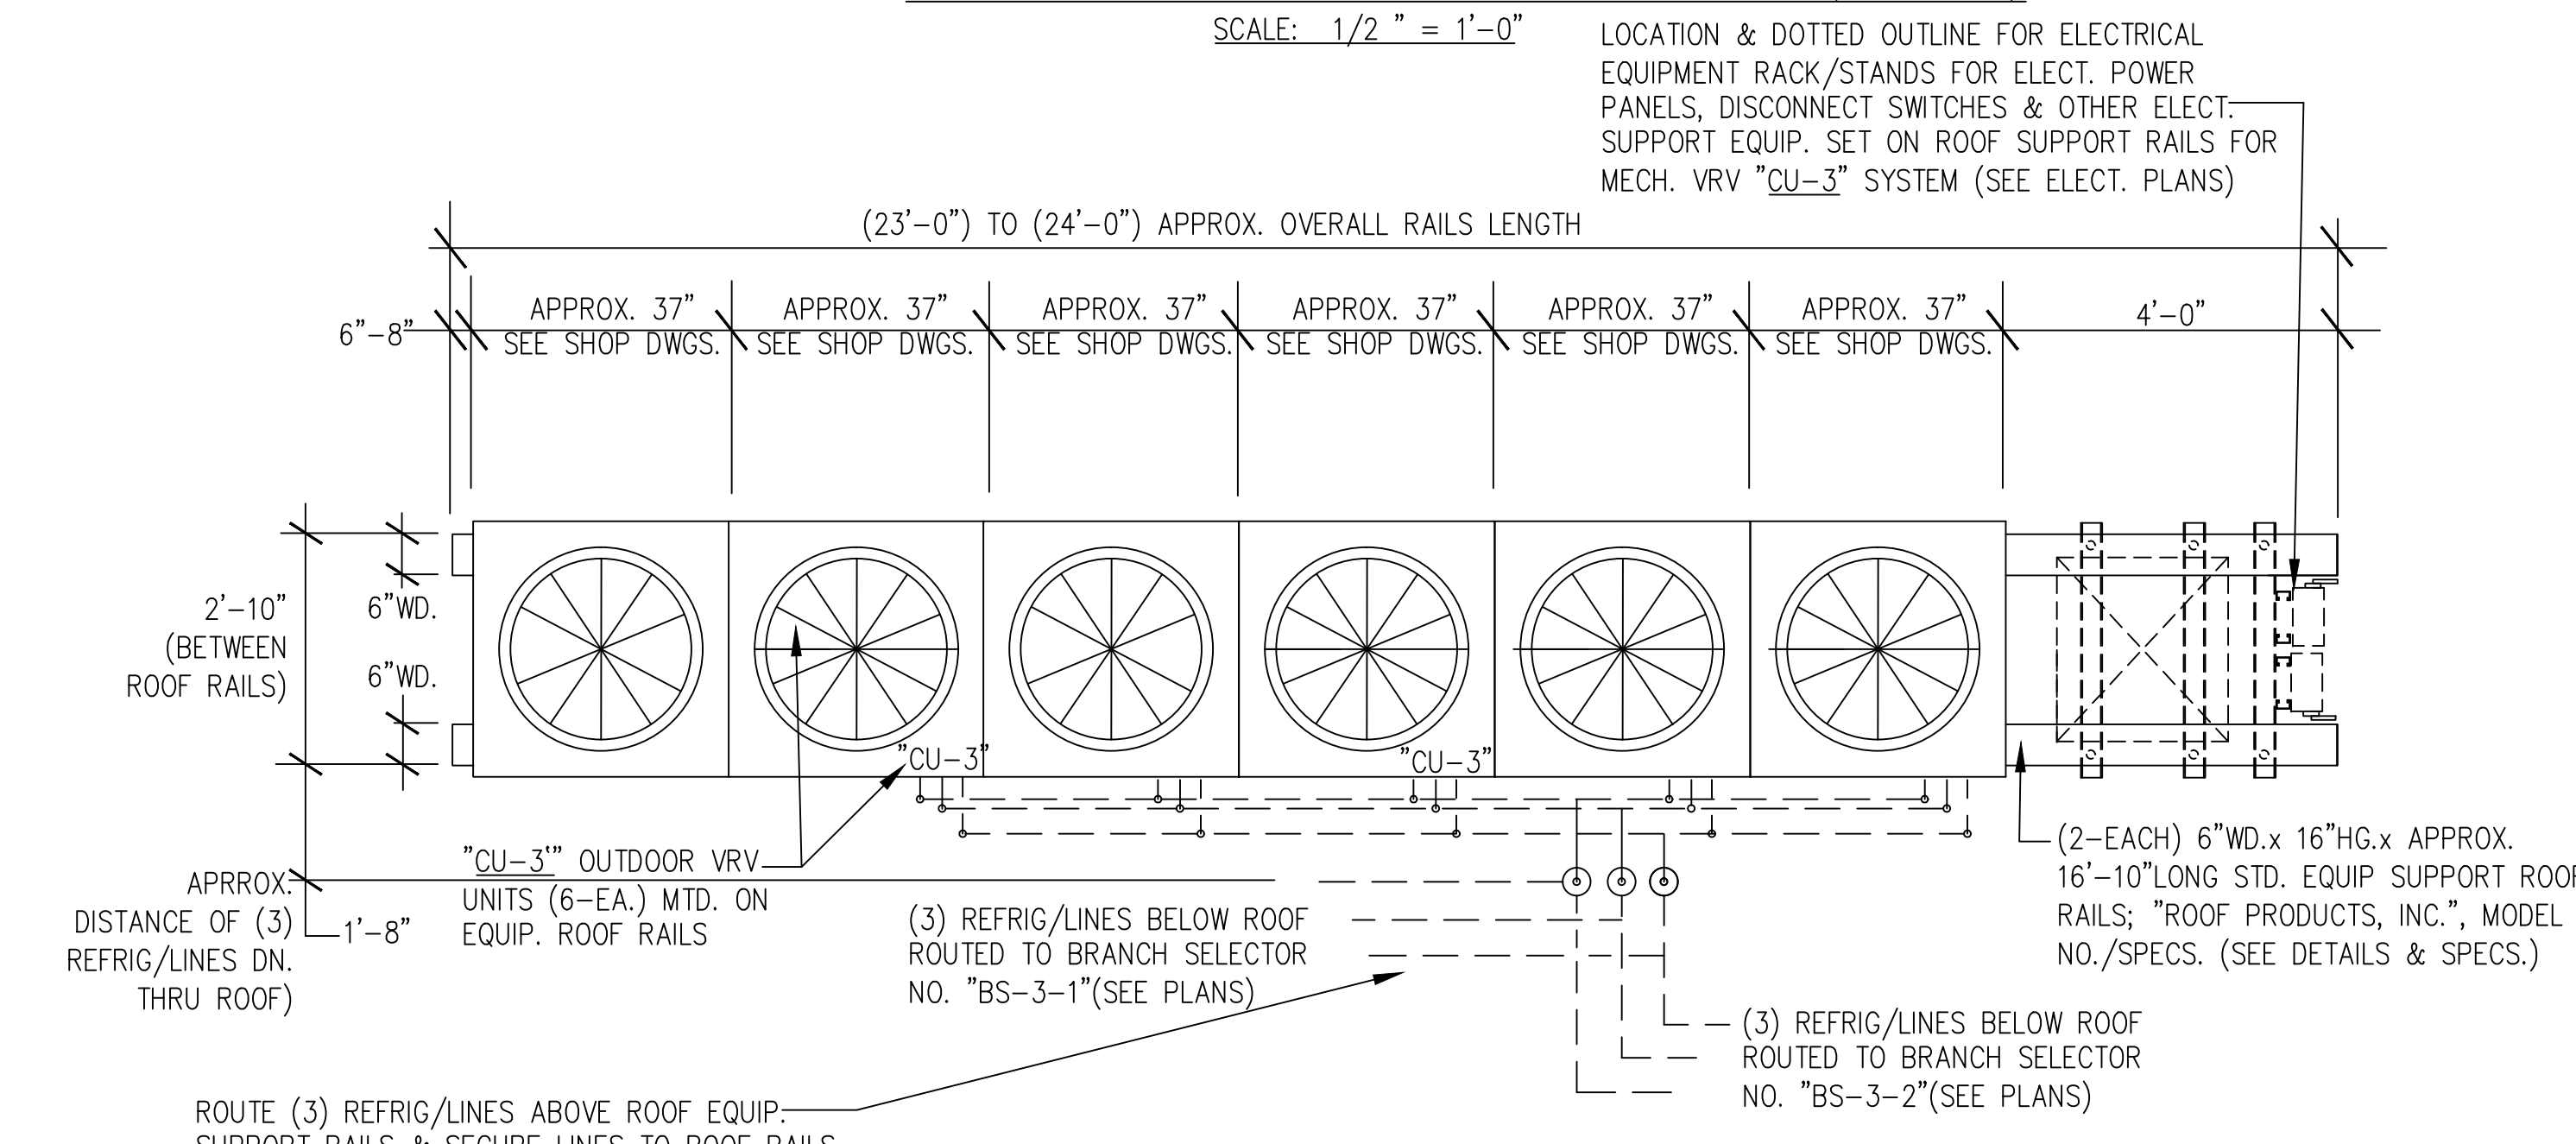

**RUGBY - ENLARGED HVAC ROOF PLAN @ NEW "CU-3" VRV ZONE NO. 3 OUTDOOR UNITS (RUGBY)**

SCALE: 1/2" = 1'-0"

(RUGBY) - NEW VRV ("IDU") INDOOR UNIT TYPE & NOMINAL CAPACITY SCHEDULE

MARK	UNIT SYMBOL	UNIT TYPE	CAPACITY
A	(A) IDU-F-F	CEILING CASSETTE w/TRIM	1/2-TON NOMINAL COOLING CAPACITY
A	(A) IDU-F-F	VERTICAL WALL MOUNTED w/TRIM	1/2-TON NOMINAL COOLING CAPACITY
B	(B) IDU-F-F	CEILING CASSETTE w/TRIM	1-TON NOMINAL COOLING CAPACITY
C	(C) IDU-F-F	CEILING CASSETTE w/TRIM	1-1/2-TON NOMINAL COOLING CAPACITY
D	(D) IDU-F-F	CEILING CASSETTE w/TRIM	2-TON NOMINAL COOLING CAPACITY
E	(E) IDU-F-F	CEILING CASSETTE w/TRIM	3-TON NOMINAL COOLING CAPACITY

**RUGBY HVAC UPGRADE NEW MECH. WORK - PART-A FLOOR PLAN @ EXIST. MAIN UPPER FLOOR (VRV ZONES 3 & 4)**

SCALE: 1/8"=1'-0" (EXIST REFERENCE PARTIAL FLOOR PLAN USED FOR NEW HVAC VRV SYSTEMS INFORMATION)